


NINILCHIK EMERGENCY SERVICES
 NEW FIRE STATION

Revised/Issued:	3-10-13 ISSUE FOR PERMITS
7-27-13 90% REVIEW	
8-5-13 ISSUE FOR CONSTRUCTION	
Date:	AUGUST 5, 2013
Checked:	BRK
Project:	1123
File Name:	
Sheet Title:	REFLECTED CEILING PLAN

Sheet: **A1.5**
 of

LEGEND

	RECESSED CAN LIGHT FIXTURE
	4'x4' LIGHT FIXTURE
	2'x4' LIGHT FIXTURE
	1'x4' LIGHT FIXTURE
	RECESSED LINEAR LIGHT FIXTURE
	RECESSED TRACK LIGHT FIXTURE
	RECESSED EMERGENCY LIGHT FIXTURE
	RECESSED EXIT LIGHT FIXTURE
	RECESSED FIRE ALARM PULL STATION
	RECESSED FIRE ALARM BELL
	RECESSED FIRE ALARM HORN
	RECESSED FIRE ALARM STROBE
	RECESSED FIRE ALARM SPEAKER
	RECESSED FIRE ALARM CONTROL PANEL
	RECESSED FIRE ALARM ANNUNCIATOR
	RECESSED FIRE ALARM MANUAL CALL POINT
	RECESSED FIRE ALARM RESET BUTTON
	RECESSED FIRE ALARM TEST BUTTON
	RECESSED FIRE ALARM TROUBLE SIGNAL
	RECESSED FIRE ALARM BATTERY CHARGER
	RECESSED FIRE ALARM CONTROL UNIT
	RECESSED FIRE ALARM CONTROL PANEL WITH ANNUNCIATOR
	RECESSED FIRE ALARM CONTROL PANEL WITH STROBE
	RECESSED FIRE ALARM CONTROL PANEL WITH HORN
	RECESSED FIRE ALARM CONTROL PANEL WITH SPEAKER
	RECESSED FIRE ALARM CONTROL PANEL WITH STROBE AND HORN
	RECESSED FIRE ALARM CONTROL PANEL WITH STROBE AND SPEAKER
	RECESSED FIRE ALARM CONTROL PANEL WITH HORN AND SPEAKER
	RECESSED FIRE ALARM CONTROL PANEL WITH STROBE, HORN, AND SPEAKER

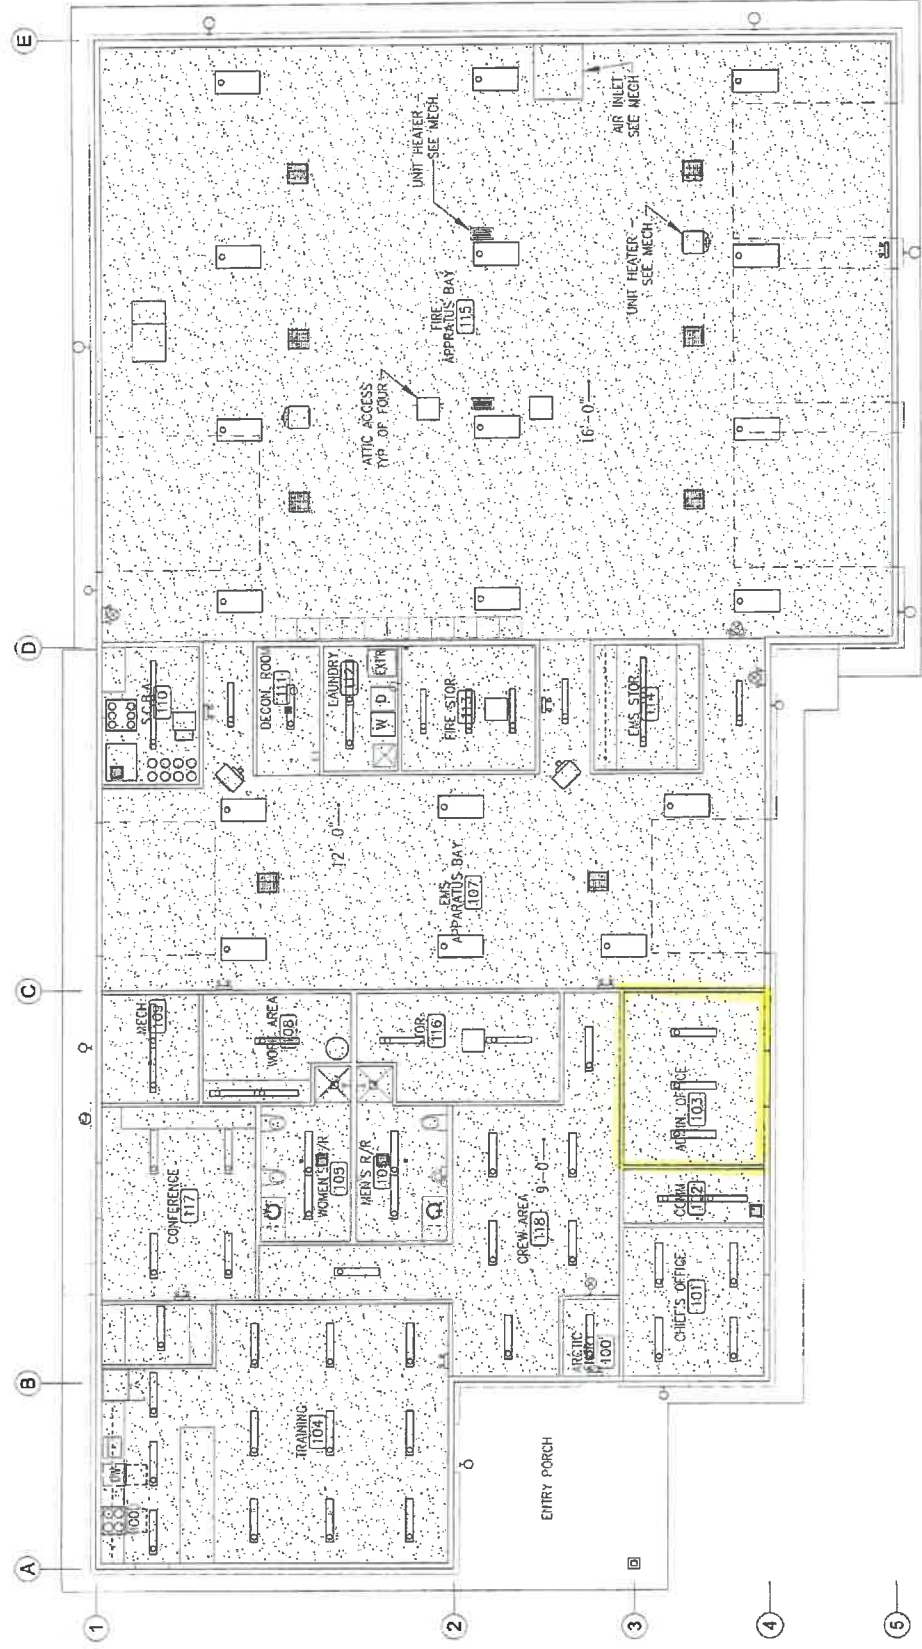

1 REFLECTED CEILING PLAN

